


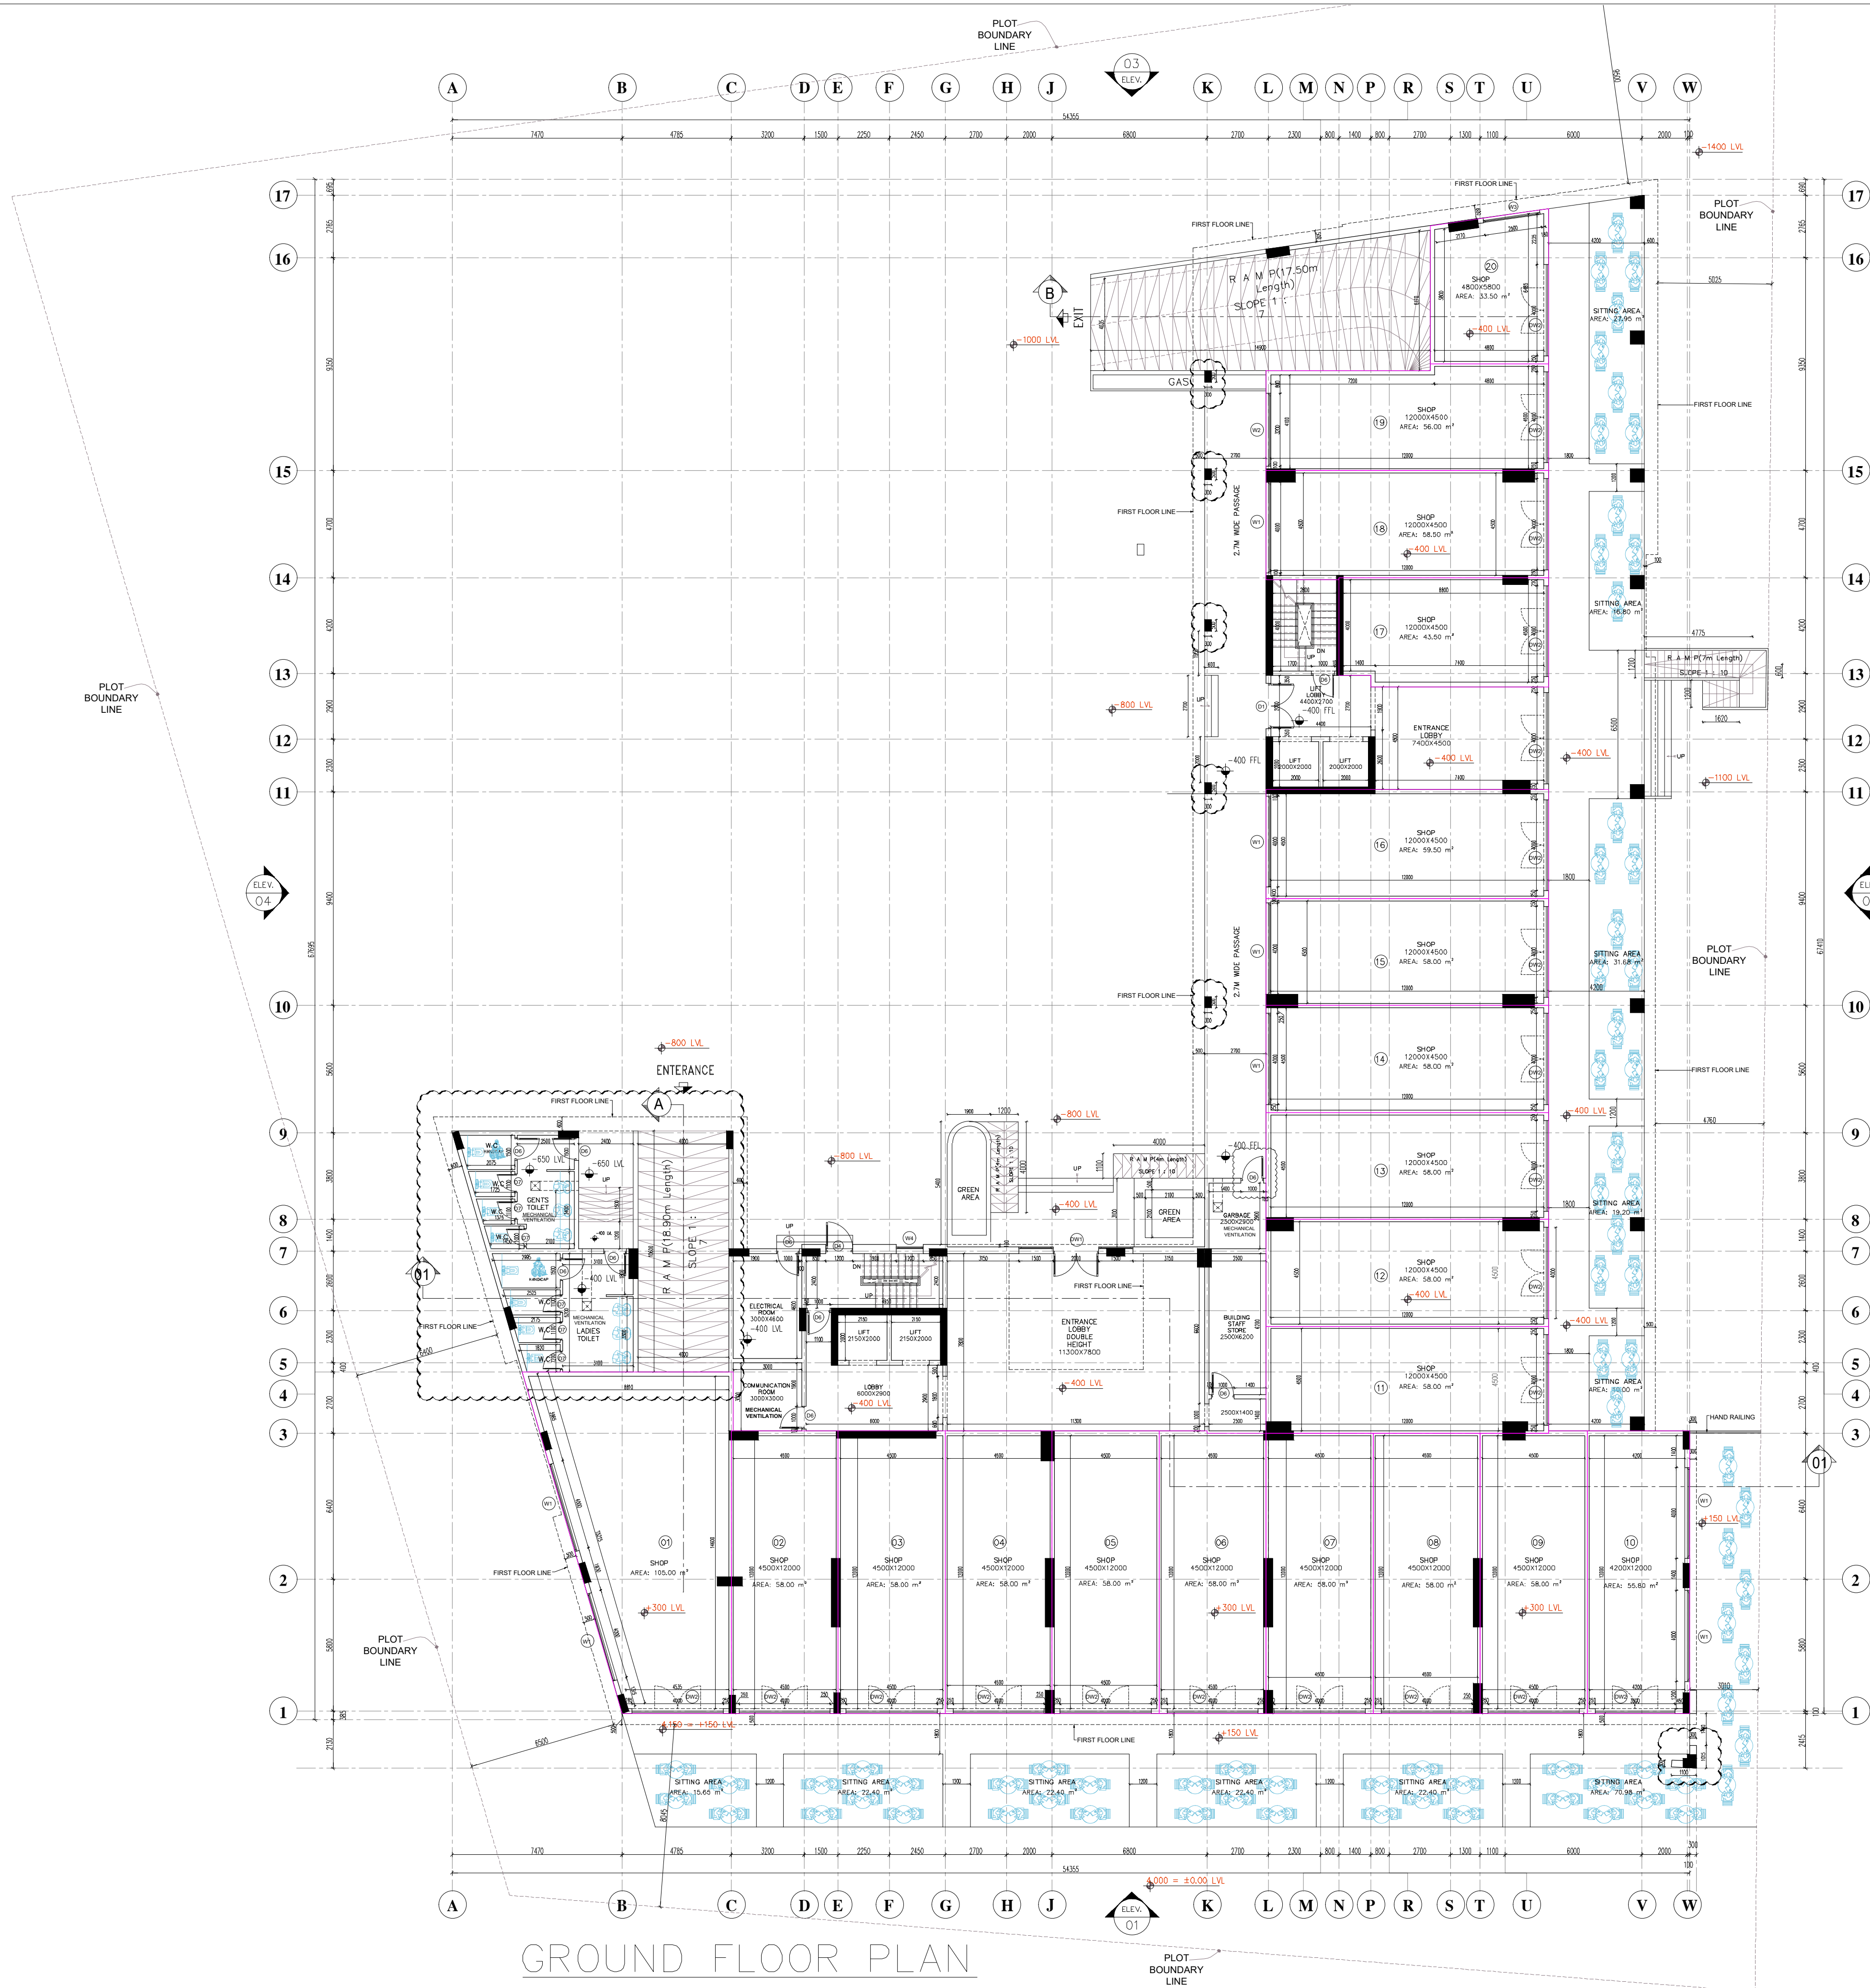

- NOTE:
1. ALL DIMENSIONS ARE IN MM UNLESS OTHERWISE NOTED
 2. DO NOT SCALE FROM THE DRAWINGS
 3. THE CONTRACTOR IS TO BRING TO THE NOTICE OF THE ENGINEER ANY DISCREPANCIES WHICH MAY BE CONTAINED IN THESE DRAWINGS PRIOR TO WORK COMMENCEMENT.
 4. ALL LEVELS ARE FINISHED FLOOR LEVEL UNLESS OTHERWISE NOTED.
 5. LEVELS:
FFL - FINISHED FLOOR LEVEL
STL - SLAB TOP LEVEL

ISSUED FOR CONSTRUCTION

NO.	DATE	REVISION	SIGN


CONSULTANT

CAPITAL
ENGINEERING CONSULTING

العاصمة
للإستشارات الهندسية

CON. No. 1177/2018, P.O. Box 3031, P.O. 129, Al Kharafiya - Tel: (966) 11566 12999999 - Mob: (966) 9773 2754 - www.capital-ec.com

PROJECT	MR. AMMAR HAMID AHMED AL GHAZALI			DRG. NO.
PROJ. NO. 056/2020	PROJECT TYPE	LOCATION		
	COMMERCIAL	BUKHARI AL GHUZHARI NORTH		
	NAME OF SHEET			
	GROUND FLOOR PLAN			
DESIGNED BY	M.SABA	SCALE	1:150 (A1 SHEET)	NOTES
DRAWN BY	AMJUN	DATE	2-05-2020	
STR. ENGR.	MR. HISHAM	ELEC. ENGR.	SHEIKH FAREED AHMAD	
CHECKED BY	MR. SABA			

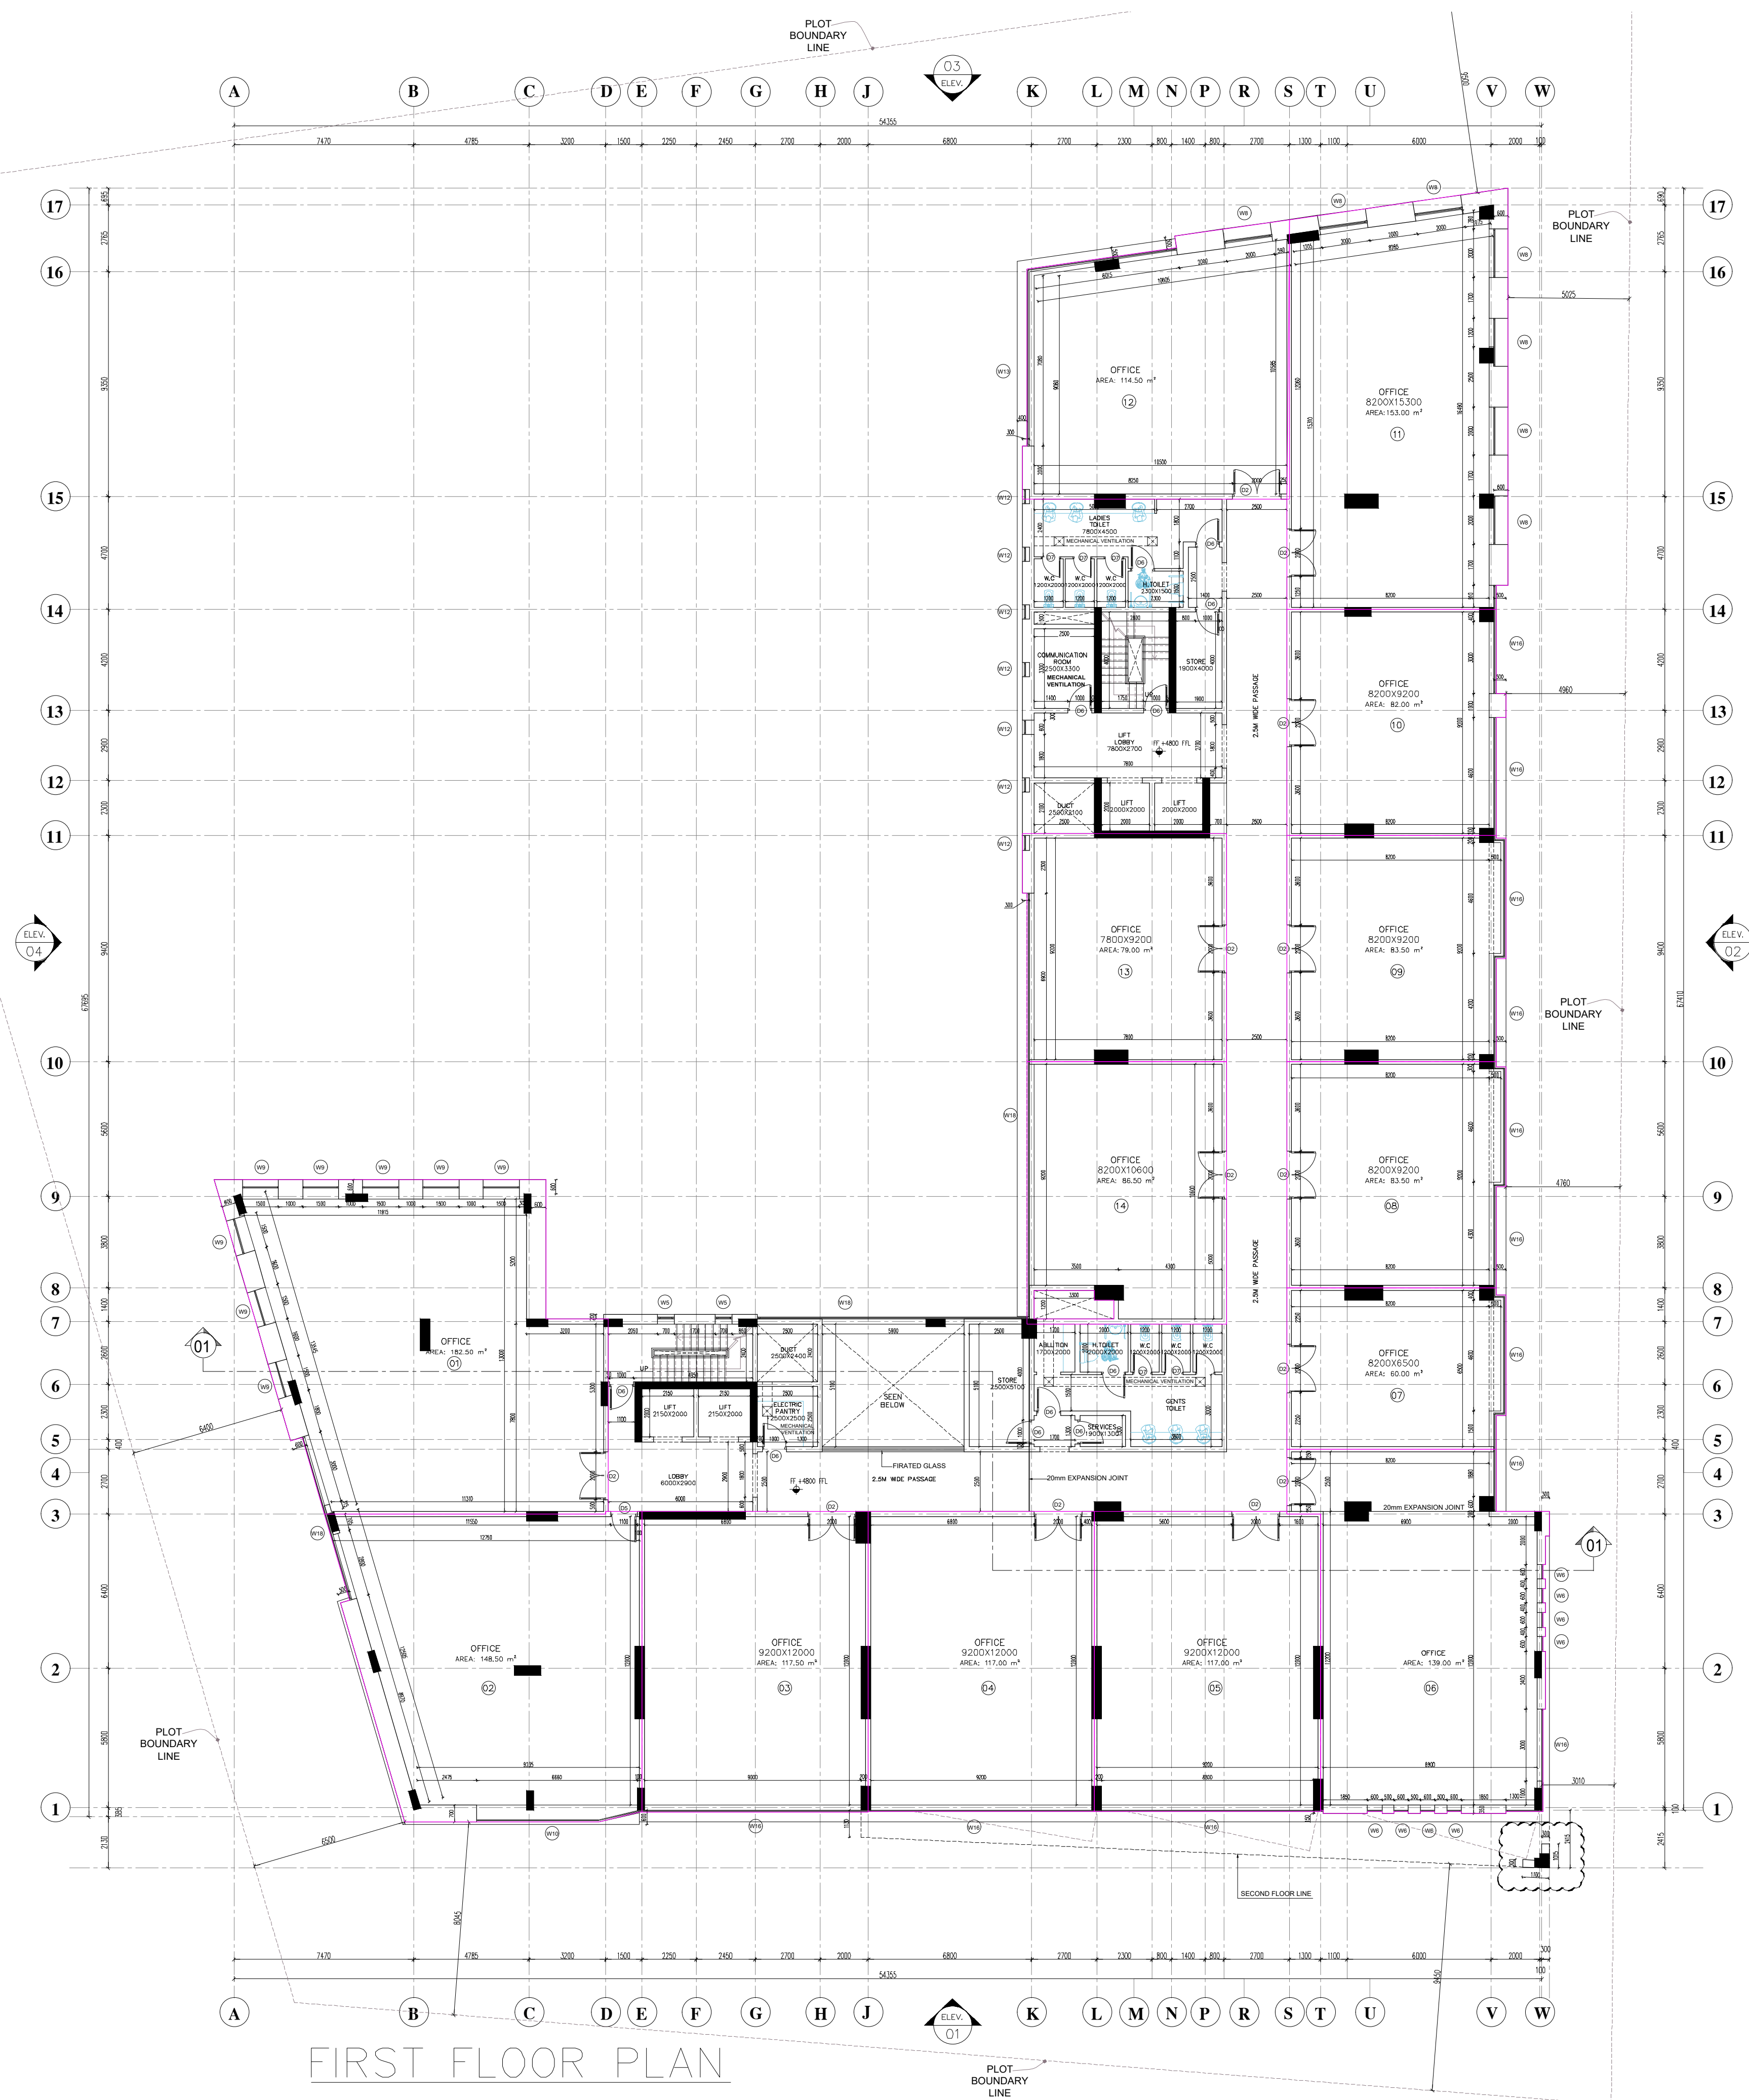

1. ALL DIMENSIONS ARE IN "MM" UNLESS OTHERWISE NOTED
2. DO NOT SCALE FROM THE DRAWINGS
3. THE CONTRACTOR IS TO BRING TO THE NOTICE OF THE ENGINEER ANY DISCREPANCIES WHICH MAY BE CONTAINED IN THESE DRAWINGS PRIOR TO WORK COMMENCEMENT.
4. ALL LEVELS ARE FINISHING FLOOR LEVEL UNLESS OTHERWISE NOTED.
5. LEVELS
 - FFL - FINISHED FLOOR LEVEL
 - STL - SLAB TOP LEVEL

ISSUED FOR CONSTRUCTION

NO.	DATE	REVISION	SIGN

CONSULTANT

**CAPITAL
ENGINEERING CONSULTING**

العاصمة
للإستشارات الهندسية


CRN No. 1317428, P.O. Box 2037, P.C. 130, Al Azaiba Tel: (+966) 24496366 Mob: (+966) 9573 3754 www.ccrn.com	
PROJECT	MR. AMMAR HAMID AHMED AL GHAZALI

PROJ. NO.	PROJECT TYPE	LOCATION	ORG. NO.
0	COMMERCIAL	PLOT NO.364 BUSHAR, AL GHUBRAH NORTH	17-0

056/202	NAME OF SHEET		AR-0
	FIRST FLOOR PLAN		REV.

DESIGNED BY	M.SABA	SCALE	1:150 (A1 SHEET)	NOTES
DRAWN BY	ARJUN	DATE	2-05-2020	

STR. ENGR.	MR. HISHAM	ELEC. ENGR.	SHEIKH FAHEEM AHMAD
CHECKED BY	MR. SABA		

 

1. ALL DIMENSIONS ARE IN MM UNLESS OTHERWISE NOTED
2. DO NOT SCALE FROM THE DRAWINGS
3. THE CONTRACTOR IS TO BRING TO THE NOTICE OF THE ENGINEER ANY DISCREPANCIES WHICH MAY BE CONTAINED IN THESE DRAWINGS PRIOR TO WORK COMMENCEMENT.
4. ALL LEVELS ARE FINISHING FLOOR LEVEL UNLESS OTHERWISE NOTED.
5. LEVELS.
 - FFL - FINISHED FLOOR LEVEL
 - STL - SLAB TOP LEVEL

NO.	DATE	REVISION	SIGN

**CAPITAL
ENGINEERINGCONSULTING**

العاصمة
للإستشارات الهندسية

PROJ. NO.	PROJECT TYPE	LOCATION	ORG. NO.
0	COMMERCIAL	PLOT NO.364 BUSHAR, AL GHUBRAH NORTH	

056/2022

NAME OF SHEET	
THIRD FLOOR PLAN	

DESIGNED BY	M.SABA	SCALE	1:150 (A1 SHEET)	NOTE
DRAWN BY	ARUN	DATE	2-05-2020	
STR. ENGR.	MR. HISHAM	ELEC. ENGR.	SHEIKH FAHEEM AHMAD	
CHECKED BY	MR. SABA			



- NOTE:
1. ALL DIMENSIONS ARE IN MM UNLESS OTHERWISE NOTED
 2. DO NOT SCALE FROM THE DRAWINGS
 3. THE CONTRACTOR IS TO BRING TO THE NOTICE OF THE ENGINEER ANY DISCREPANCIES WHICH MAY BE CONTAINED IN THESE DRAWINGS PRIOR TO WORK COMMENCEMENT.
 4. ALL LEVELS ARE FINISHED FLOOR LEVEL UNLESS OTHERWISE NOTED.
 5. LEVELS:
F.F.L. - FINISHED FLOOR LEVEL
S.L. - SLAB TOP LEVEL

ISSUED FOR CONSTRUCTION

NO.	DATE	REVISION	SIGN


CONSULTANT

CAPITAL ENGINEERING CONSULTING

العاصمة للاستشارات الهندسية

066/2020

PROJECT	MR. AMMAR HAMID AHMED AL GHAZALI		
PROJ. NO.	PROJECT TYPE	LOCATION	DRG. NO.
066/2020	COMMERCIAL	PLANT NO. 364 BUSHAR AL GHUBRAH NORTH	AR-07
DESIGNED BY	SCALE	1:150 (A1 SHEET)	REV.
DRAWN BY	DATE	2-05-2020	00
STR. ENGR.	MR. HISHAM	ELEC. ENGR. SHEIKH FAREED AHMAD	NOTES
CHECKED BY	MR. SAHA		

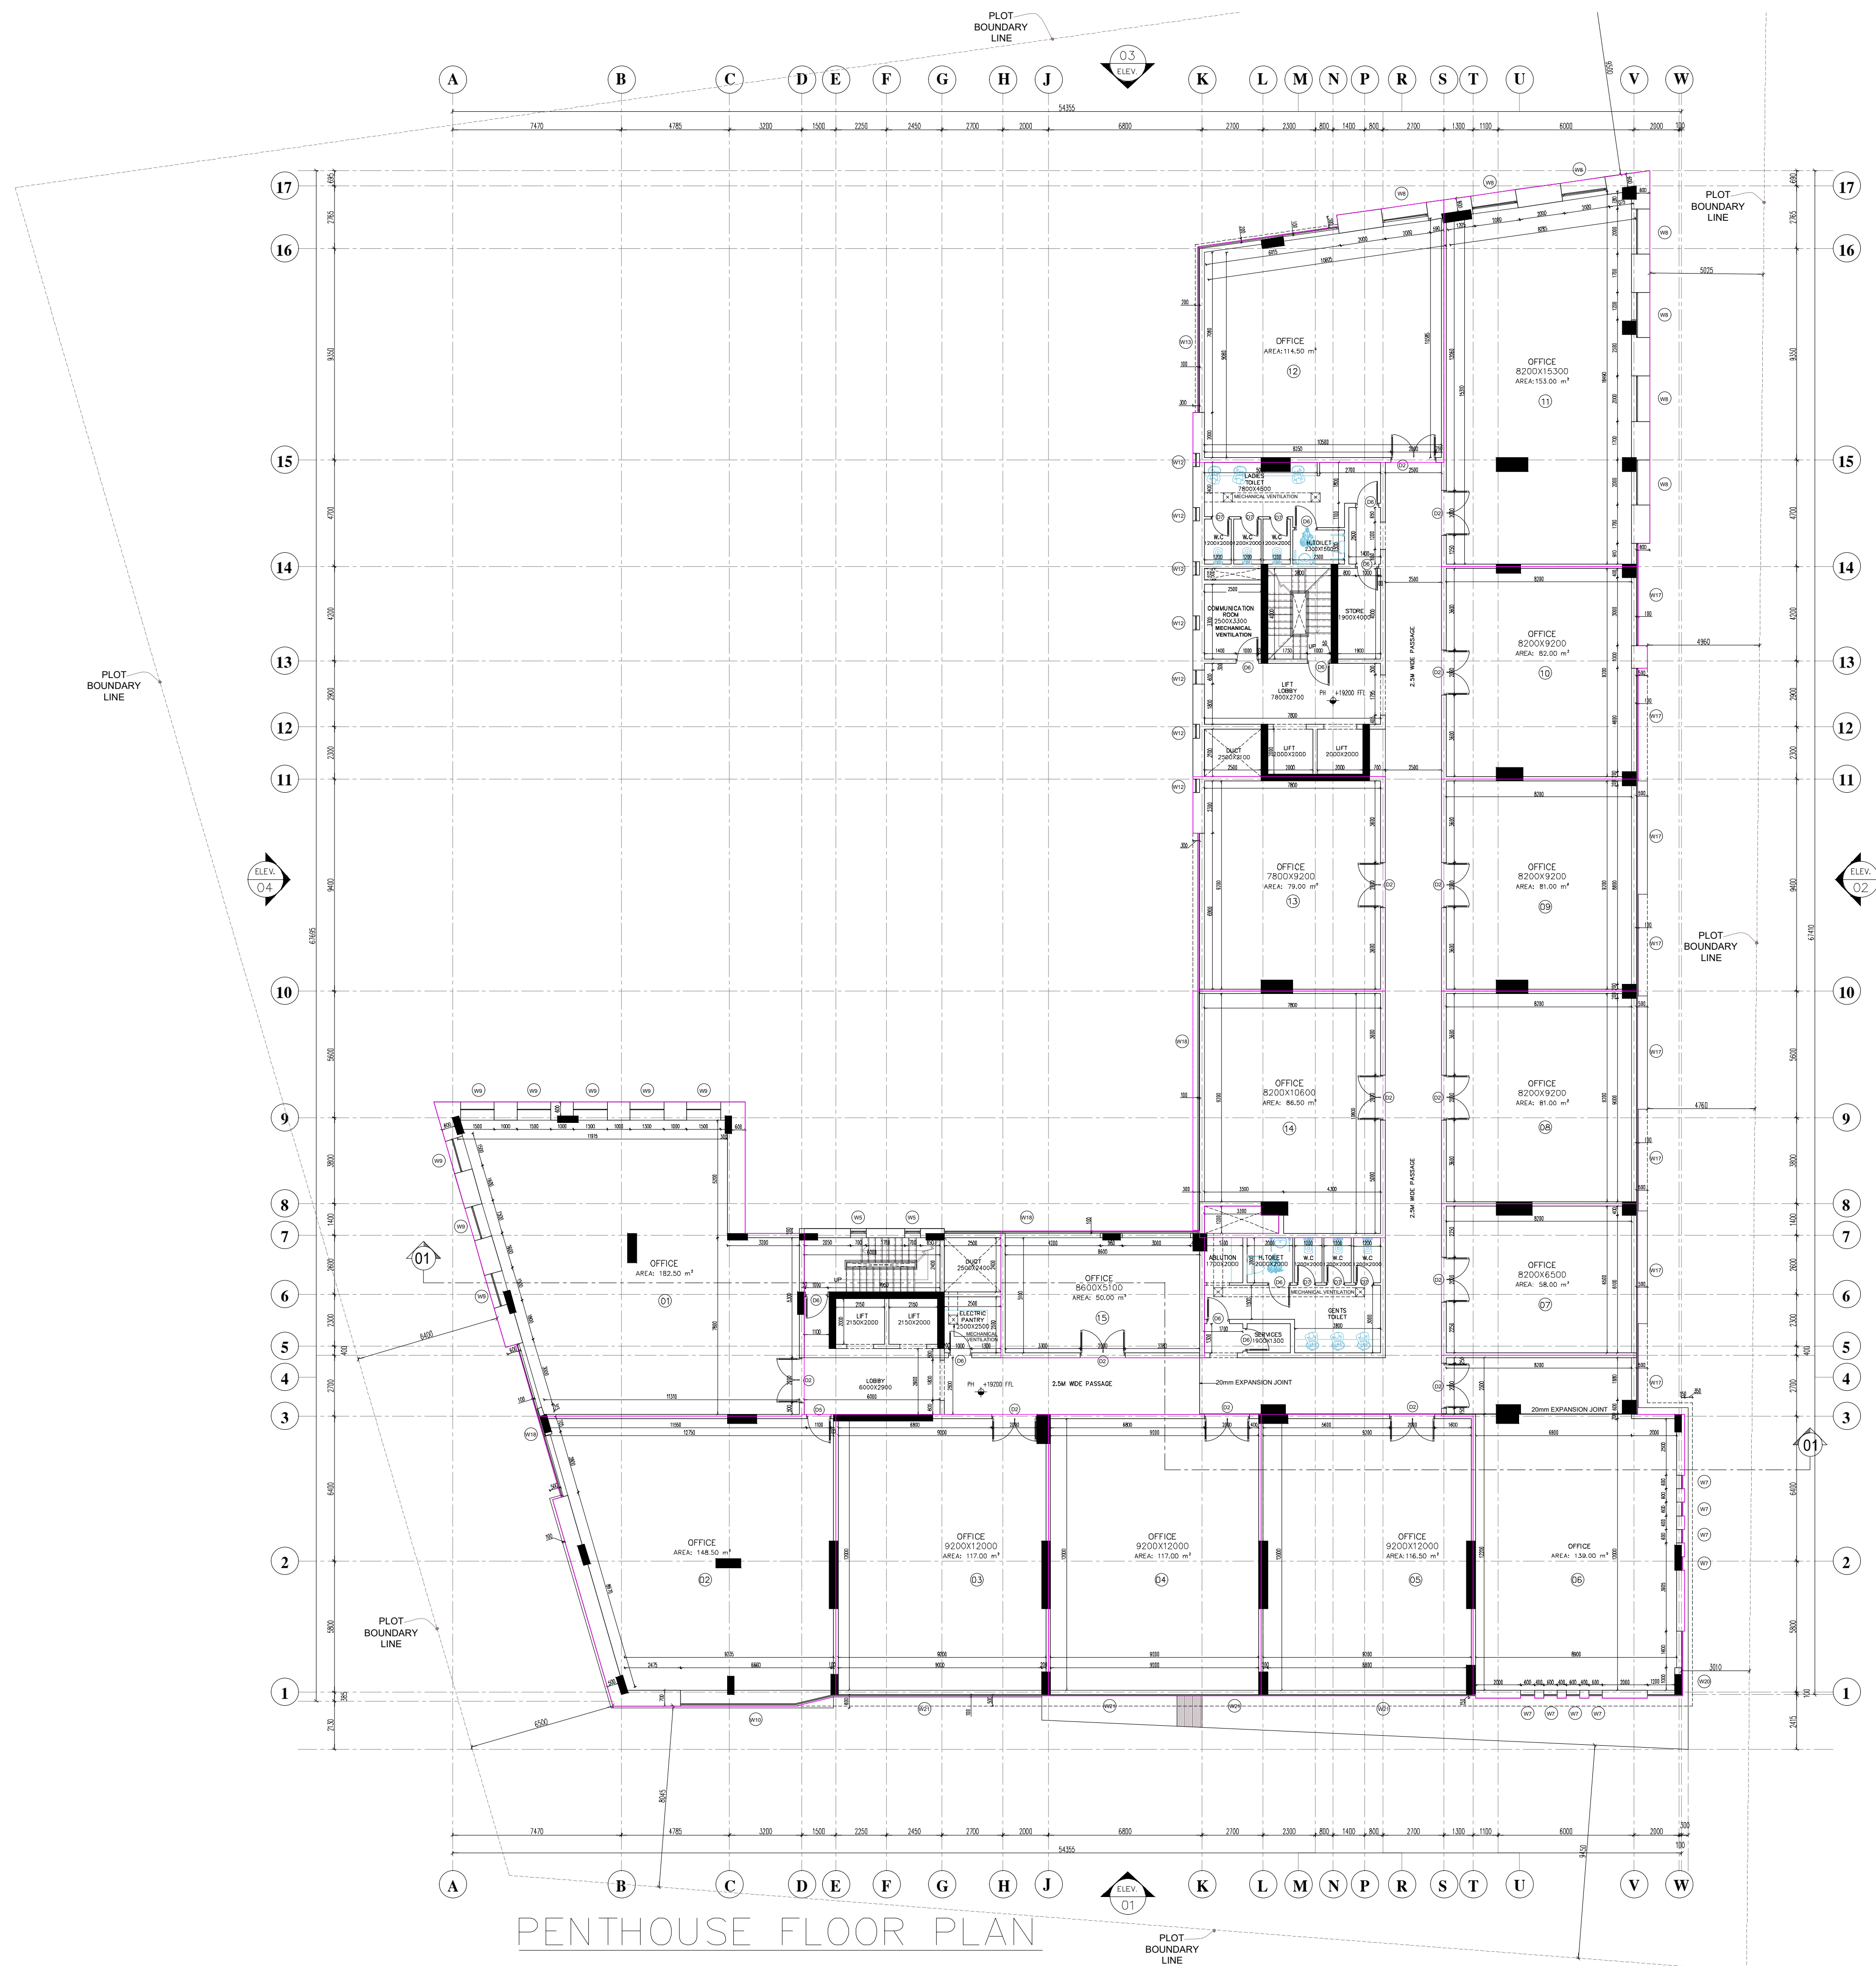

- NOTE:
1. ALL DIMENSIONS ARE IN MM UNLESS OTHERWISE NOTED
 2. DO NOT SCALE FROM THE DRAWINGS
 3. THE CONTRACTOR IS TO BRING TO THE NOTICE OF THE ENGINEER ANY DISCREPANCIES WHICH MAY BE CONTAINED IN THESE DRAWINGS PRIOR TO WORK COMMENCEMENT.
 4. ALL LEVELS ARE FINISHED FLOOR LEVEL UNLESS OTHERWISE NOTED.
 5. LEVELS:
FFL - FINISHED FLOOR LEVEL
STL - SLAB TOP LEVEL

ISSUED FOR CONSTRUCTION

NO.	DATE	REVISION	SIGN

CONSULTANT

CAPITAL ENGINEERING CONSULTING  **العاصمة للاستشارات الهندسية**

CON. No. 1177/2018, P.O. Box 3331, P.O. 126, Al Kharafah - Tel: (+966) 1146612345 - Mob: (+966) 99773 2754 - www.capital-engineer.com

PROJECT		MR. AMMAR HAMID AHMED AL GHAZALI		
PROJ. NO. 056/2020	PROJECT TYPE	LOCATION		DRG.NO. AR - OB
	COMMERCIAL	PLOT NO.364 BUSHAR, AL GHUZHARA NORTH		
	NAME OF SHEET			REV.
	PENTHOUSE FLOOR PLAN			00
DESIGNED BY	M.SABA	SCALE	1:150 (A1 SHEET)	NOTES
DRAWN BY	ARJUN	DATE	2-05-2020	
STR. ENGR.	MR. HISHAM	ELEC. ENGR.	SHEIKH FAHEEM AHMAD	
CHECKED BY	MR. SABA			